


LEGEND

- STAINLESS STEEL FLOOR DRAIN
- NEW CONCRETE DRAINAGE CHANNEL (WITH S.S. GRID)
- NEW STAINLESS STEEL BOX CHANNEL (170MM WIDE, SUPPLIER SPEC)
- EXISTING CONCRETE CHANNEL
- uPVC 160MM DIA PIPE
- uPVC 110MM DIA PIPE
- uPVC 50MM DIA PIPE
- uPVC 75 DIA PIPE

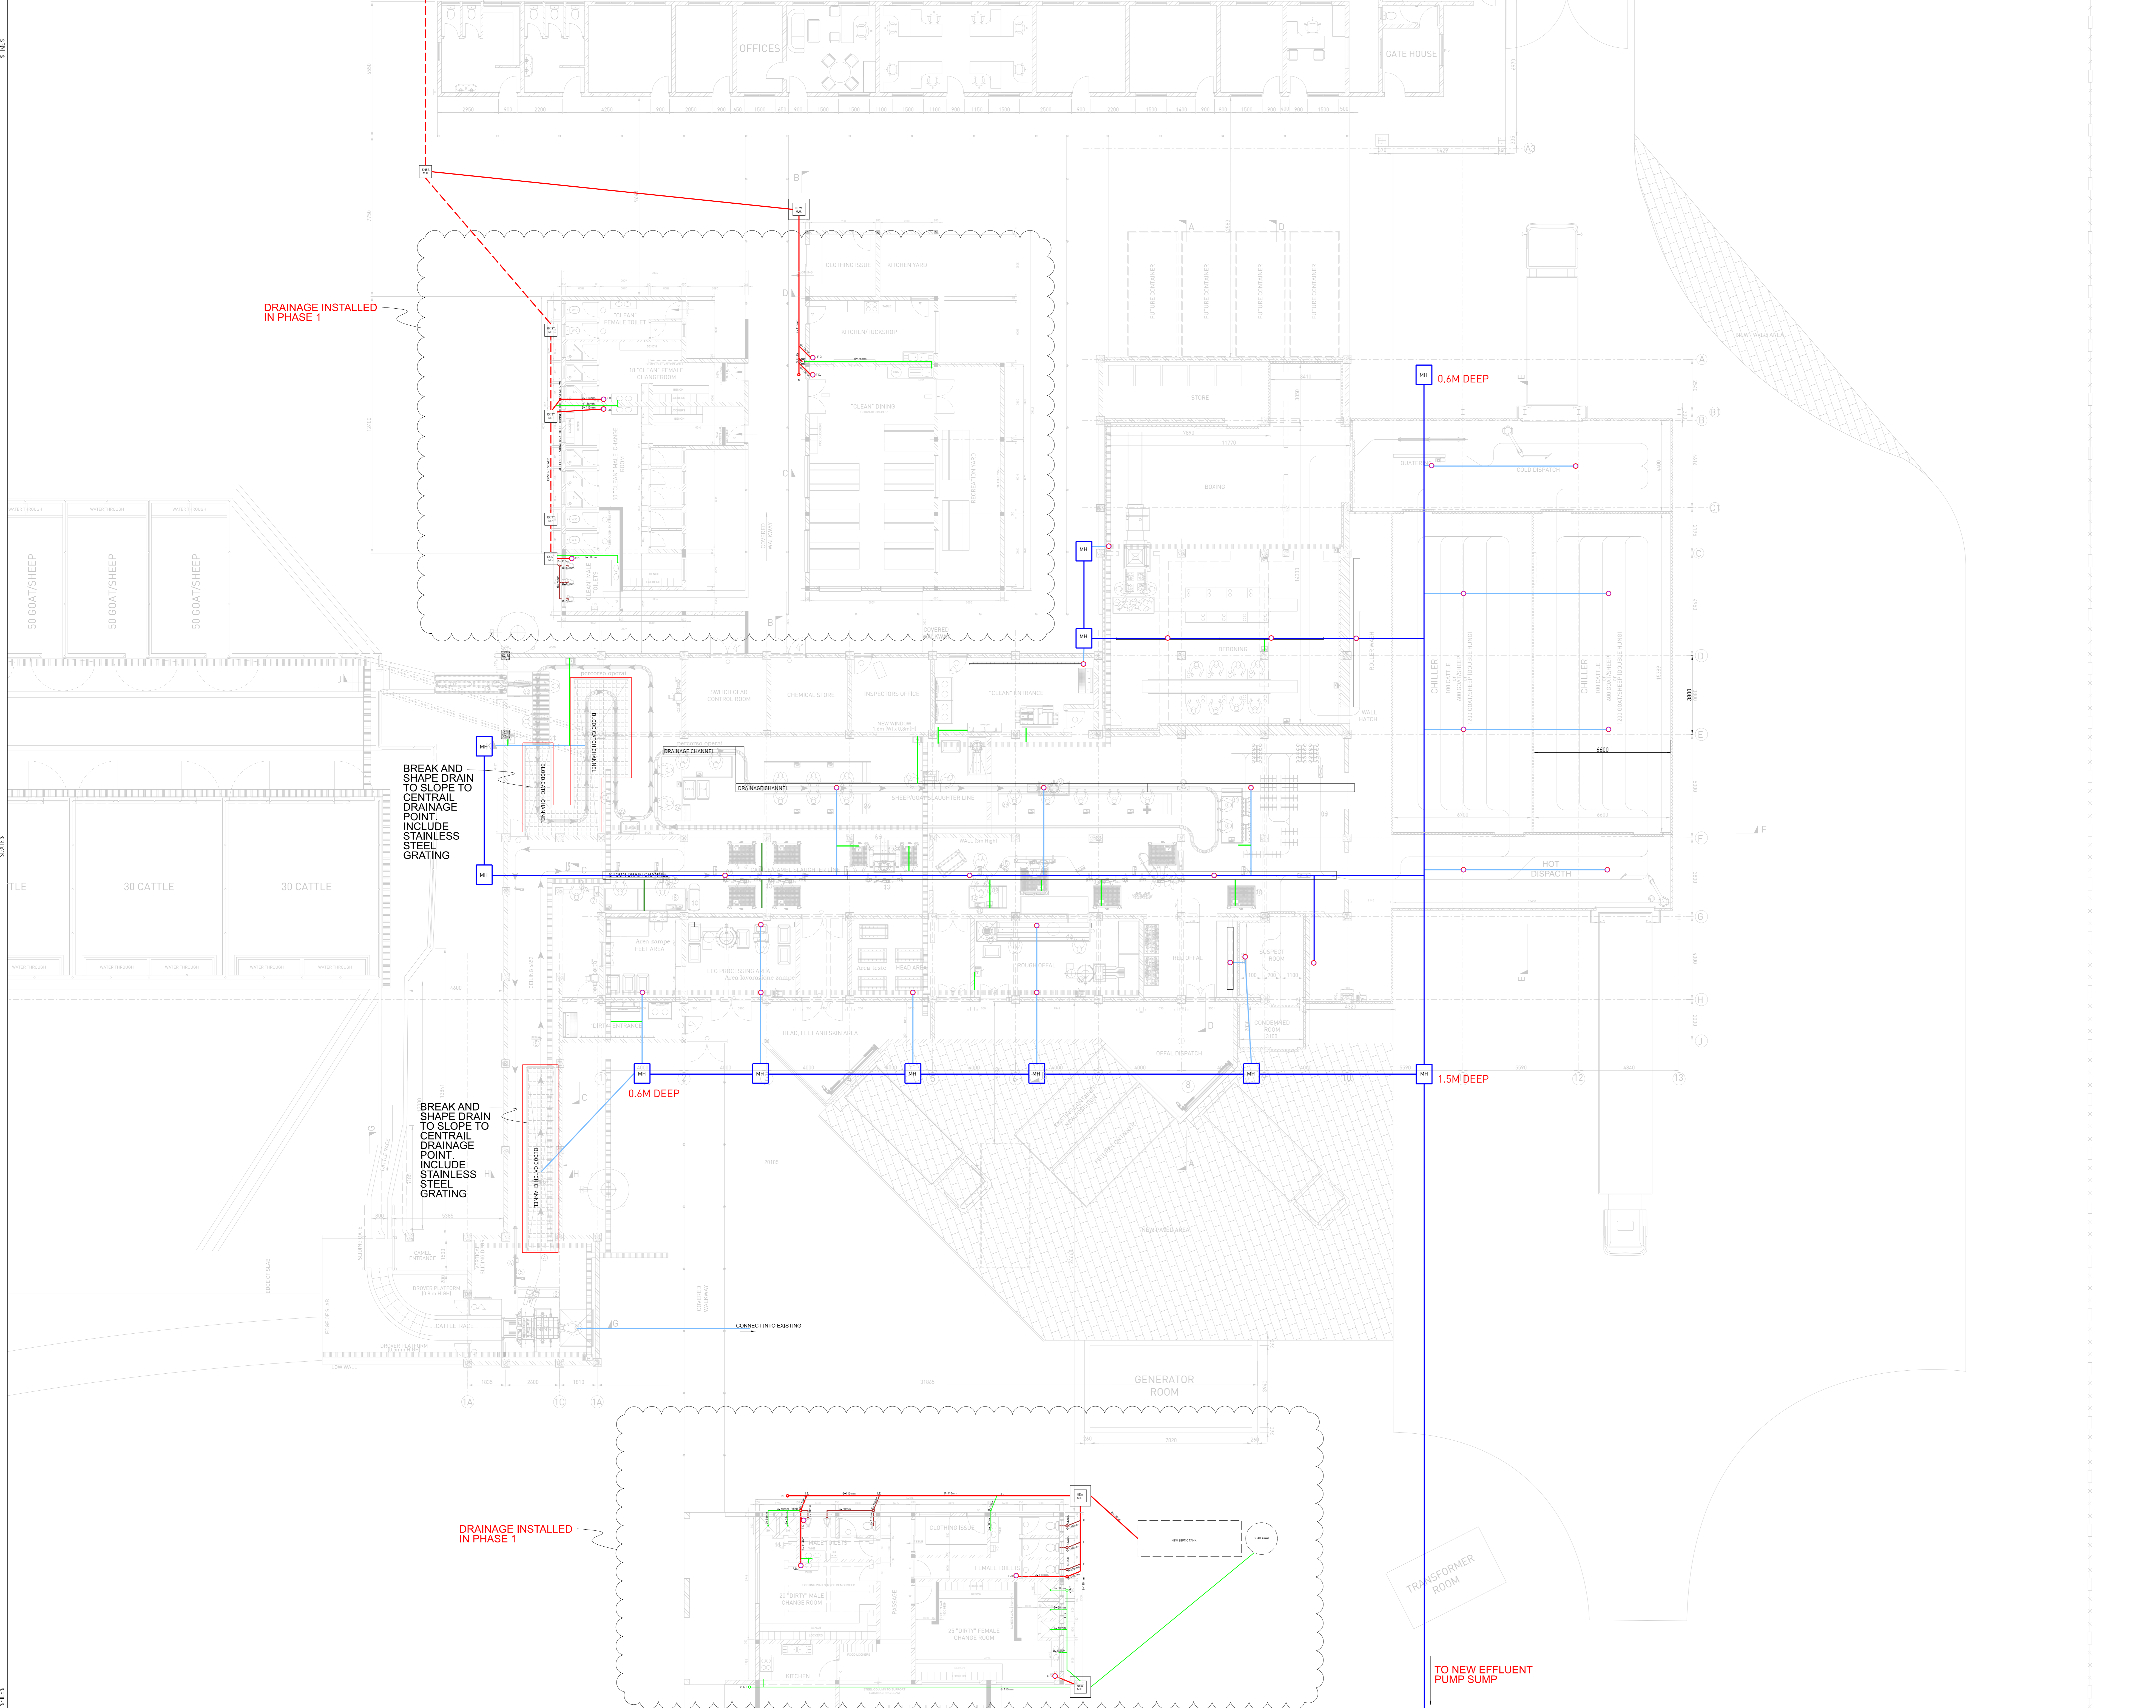

A	2023-02-13	ISSUED FOR TENDER	PF
NO.	DATE	REVISION	BY

SCIP ENGINEERING GROUP
 JOHANNESBURG
 WITSBANK

IN PARTNERSHIP WITH:
W
 VAN VLIET DE WET & PARTNERS

PO Box 48550
 Rosebank Park, 2127
 Johannesburg
 Gauteng

Tel: 011 888 1425
 Fax: 011 888 1075
 jehurg@scip.co.za
 www.scip.co.za

CLIENT **ISIOLO COUNTY ABATTOIR**

PROJECT **KENYA CLIMATE SMART AGRICULTURE**

DESCRIPTION **DRAINAGE LAYOUT**

DESIGNED	-	SCALE	1:200	PAPER SIZE	A0
DRAWN	GM	DATE	DEC 2020		
CHECKED	-	CONCRETE	✓	TENDER	○
SIGNED	-	CONSTRUCTION	○	AS BUILT	○
DRAWING NO.	1898-C3-01	REVISION	-		